



NE 1/4 SEC 32 T29S R5W WM
SE 1/4 SEC 32 T29S R5W WM

FILED
Date: 4-29-2013 By: X
This survey consists of:
Map: CO. RD. # 41A
Narrative: _____
Corner Rpt: 7 Sheets
DOUGLAS COUNTY SURVEYOR

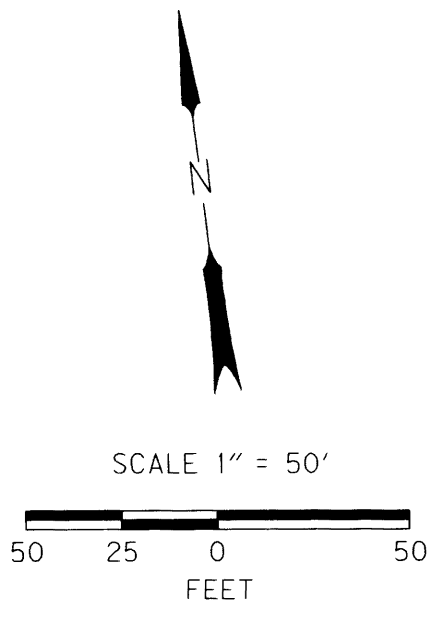

STATION "W" 15+00.00 BEARS:
N85°58'15"W, 5598.93 FEET
FROM THE EAST 1/4 CORNER OF
SECTION 33 T29S, R 5W W.M.
(PT. NO. 1050)

U.S. INTERSTATE
HIGHWAY NO. 5

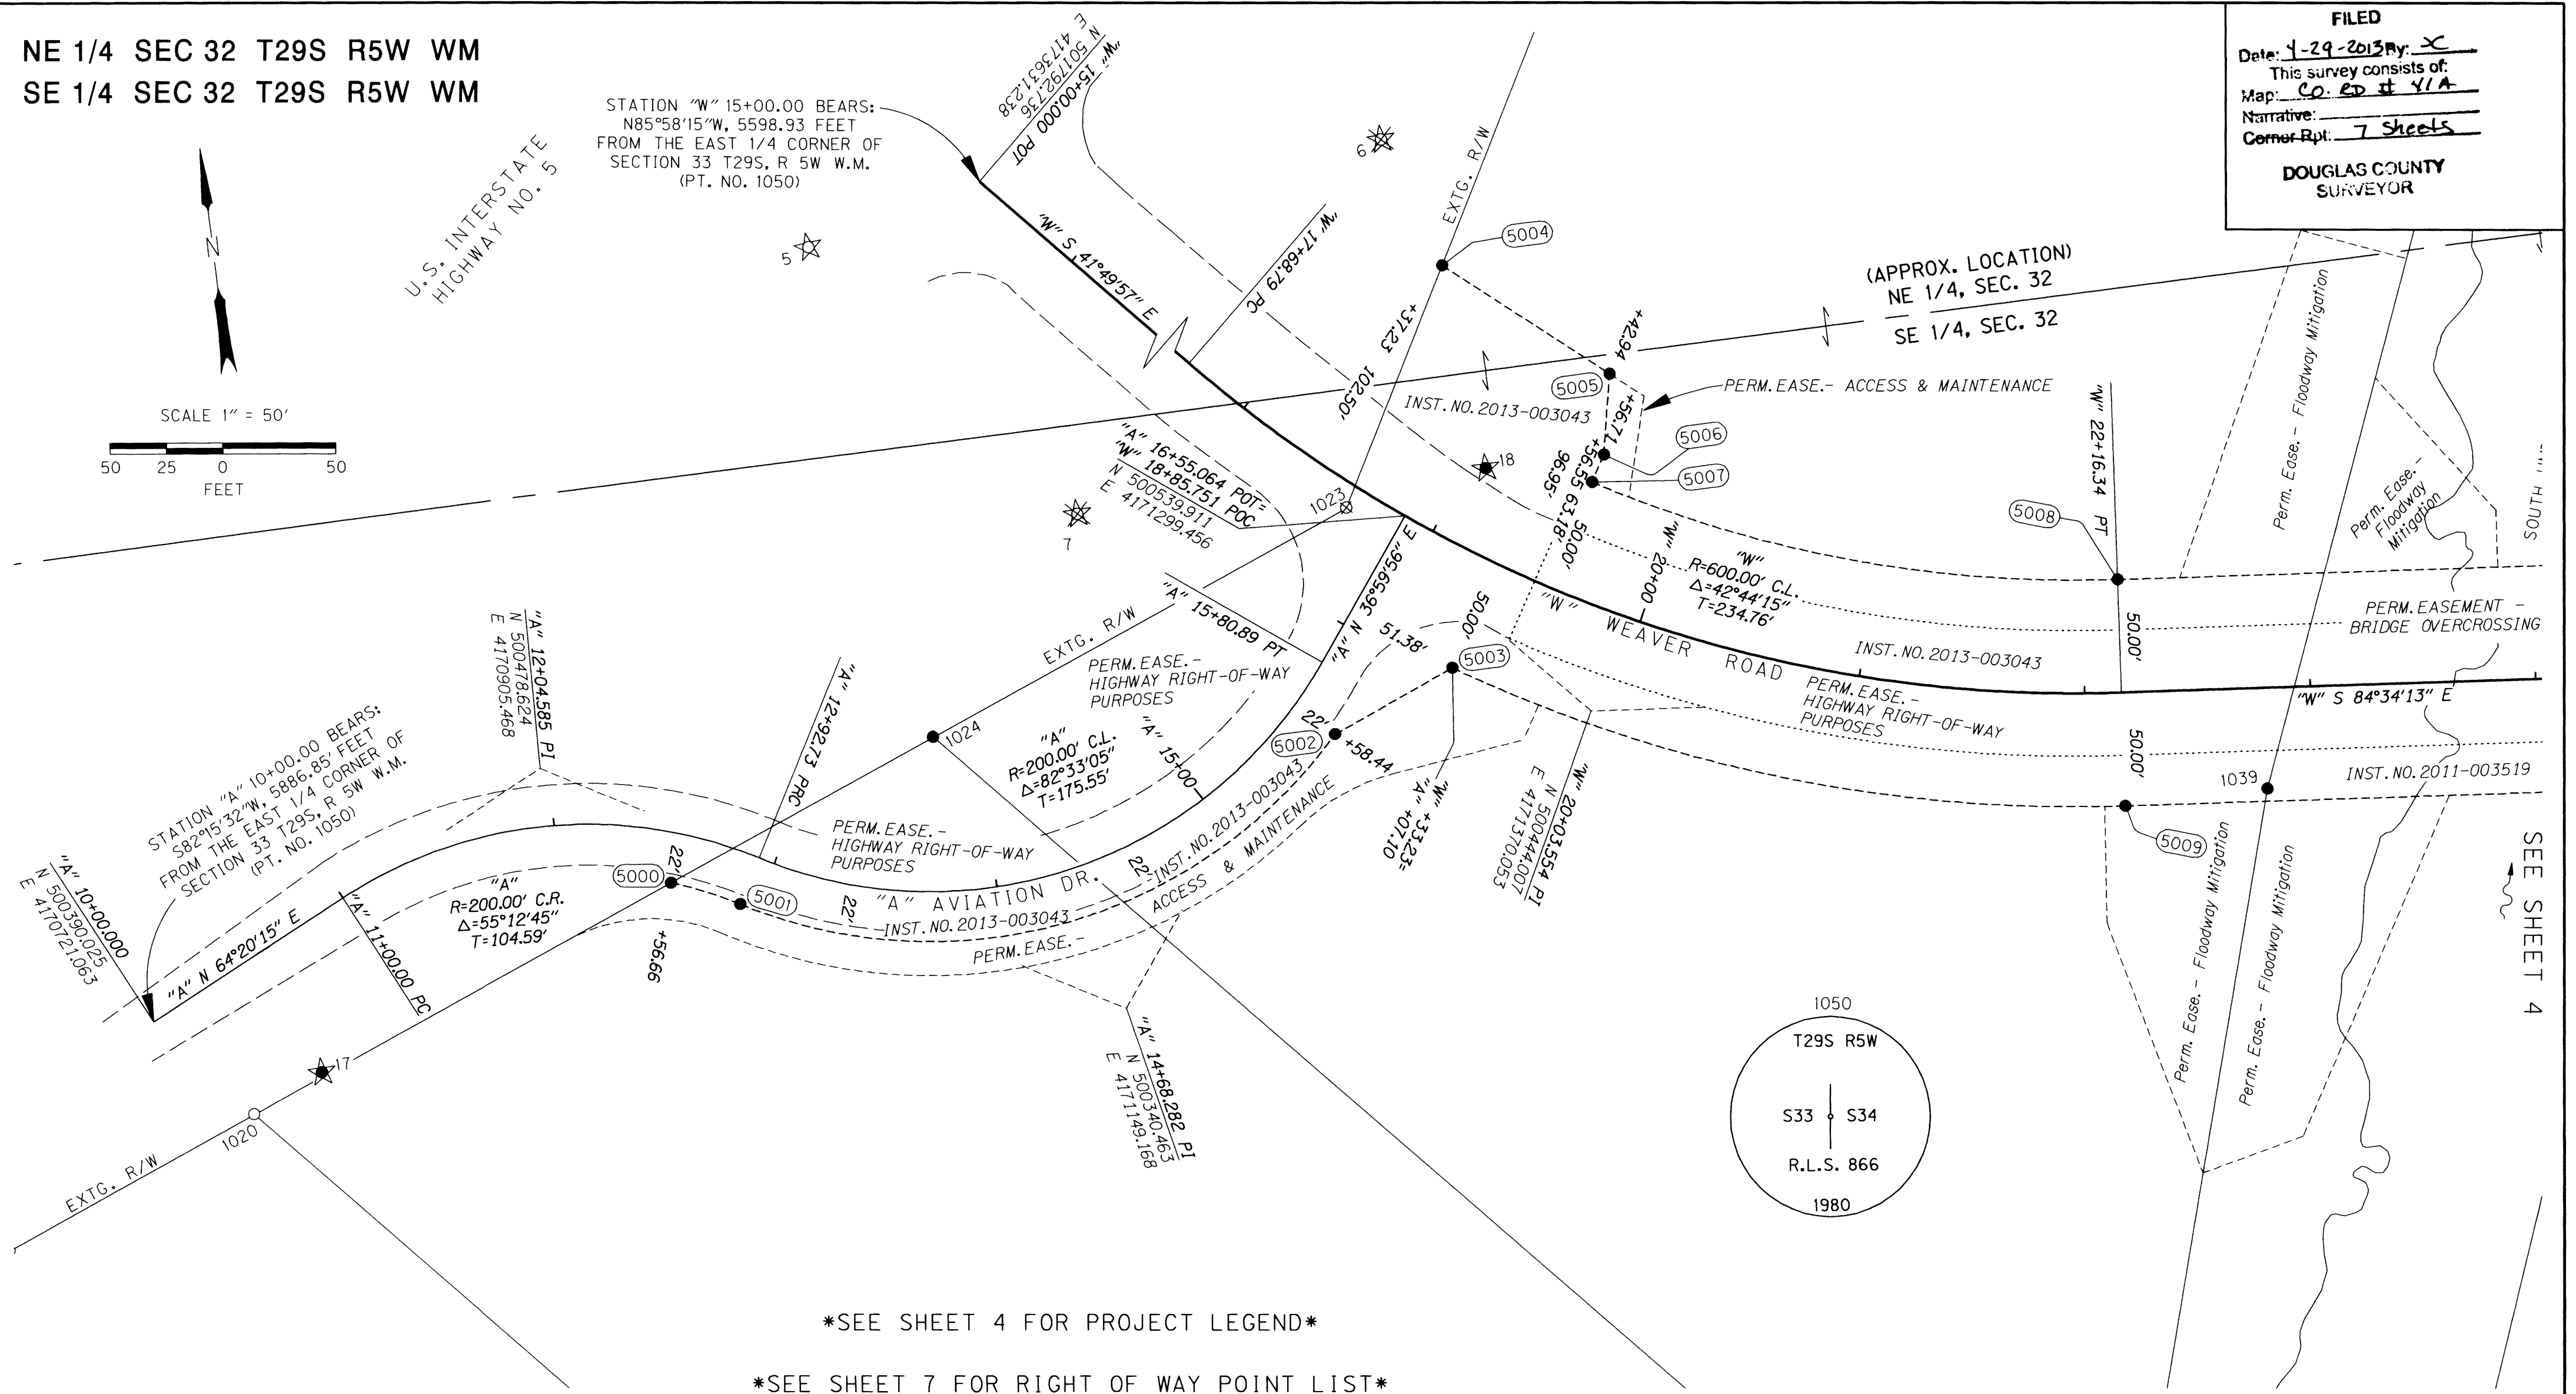

SEE SHEET 4 FOR PROJECT LEGEND

SEE SHEET 7 FOR RIGHT OF WAY POINT LIST

FND = FOUND
I.D. = INSIDE DIAMETER
YPC = YELLOW PLASTIC CAP
BPC = BLUE PLASTIC CAP
* = MONUMENT DESTROYED DURING CONSTRUCTION
D.C.S.O. = DOUGLAS COUNTY SURVEYOR'S OFFICE

RECOVERED MONUMENT LIST FROM CS ST. HWY 99-005

PT. NO.	LDP NORTHING	LDP EASTING	STATION	OFFSET	DESCRIPTION & REFERENCE DOCUMENTS
1020	500343.93	4170759.89	("L" 87+58.12)	(292.94' LT)	FND 5/8" IRON ROD W/YPC "R BROWN PLS 2391" EXPOSED 0.1', PER M136-76
1023*	500546.86	4171274.15	("L" 82+39.63)	(484.80' LT)	5/8" IRON ROD W/ 1-1/2" ALUMINUM CAP "OREGON STATE HWY. DEPT. FLUSH
1024*	500470.07	4171079.66	("L" 84+35.75)	(412.27' LT)	5/8" IRON ROD W/YPC "LS 866", EXPOSED 0.7', PER M99-80, RESET 5/8" X 30" IRON ROD W/BPC MARKED "OBEC"
1039*	500371.54	4171662.47	N/A	N/A	1" I.D. IRON PIPE, FLUSH, PER CS 46/157, RESET 5/8" X 30" IRON ROD W/BPC MARKED "OBEC"
1050	500425.80	4176619.29	N/A	N/A	FND 1" I.D. IRON PIPE W/2-1/2" BRASS CAP "T29S R5W, S33 S34, R.L.S. 866, 1980", EXPOSED 0.4', PER D.C.S.O.

REGISTERED PROFESSIONAL LAND SURVEYOR

ARON JAMES CUTSFORTH
65696
RENEWAL: DEC. 31, 2013
4/9/2013

OBEC CONSULTING ENGINEERS
Corporate Office: 920 COUNTRY CLUB ROAD, SUITE 100B EUGENE, OREGON 97401-6089, 541-683-6090
2235 MISSION STREET SE, SUITE 100 SALEM, OREGON 97302-1295, 503-589-4100
831 O' HARE PARKWAY MEDFORD, OREGON 97504-4005, 541-774-5590
5005 SW MEADOWS ROAD, SUITE 120 LAKE OSWEGO, OREGON 97035, 503-620-6103

OREGON DEPARTMENT OF TRANSPORTATION & DOUGLAS COUNTY PUBLIC WORKS
RIGHT OF WAY BOUNDARY MONUMENTATION SURVEY
WEAVER ROAD EXTENSION
OLD PACIFIC HIGHWAY
DOUGLAS COUNTY
ODOT REGION 3
3500 NW STEWART PARKWAY
ROSEBURG, OR. 97470
KEY # 14085
APRIL, 2013
SCALE 1" = 50'
SHEET 3 OF 7
DESIGNED: A. CUTSFORTH
DRAWN: L. MILES
CHK'D: B. ELITHORP
PROJ. NO. 19-84.57

Co. Rd. # 41A MP 0.00 - 0.17

CO. RD. # 41A

41A
3

00000017

FILE NAME: 14085mon.dgn

SEE SHEET 4